

NOTES

**CIVIL ENGINEERING DRAWING**  
 Drawing has been prepared for compliance with the  
 Regulation and is  
**Approved**

Permit Engineer...  
*Shahid*

Shahid Alkhalifa 12-Nov-19

This drawing approval is subject to full compliance with requirements of Trakhees-EHS and Dubai Civil Defence.



NO.	DESCRIPTION	DATE	DRAWN CHG.

CONCEPT SUBMISSION

PROJECT: **ABDULAZIZ ABDULLAH ALNOWAISR**

CONSTRUCTION: **G+1**

CONTRACT NO.: **AFNBVIL092**

LOCATION: **JABAL ALI 1ST**

CONSULTANT: **NOBLE ENGINEERING CONSULTANT**

NOBLE ENGINEERING CONSULTANT  
 HEAD OFFICE: OFFICE 409, RIVANA PLAZA, BUILDING TRISA  
 DHC, STR. RASHA ENG. NO. 109209  
 DUBAI, U.A.E. TEL: 0509118000 / 0509118001 FAX: 0509118002  
 BRANCH OFFICE: OFFICE 101, AL JABAL ALI 1ST PHASE 1, P.O. BOX 183231, DUBAI, U.A.E. TEL: 0509118000 / 0509118001 FAX: 0509118002


**FIRST FLOOR PLAN**

SCALE: **N=1** DATE: **JANUARY 2019**

SET/DRAWN: **DM-ARCH, JASSAR, ENGR. 11/16/19**

DATE: **12/11/19**

PROJECT NO.: **AR-1-03**

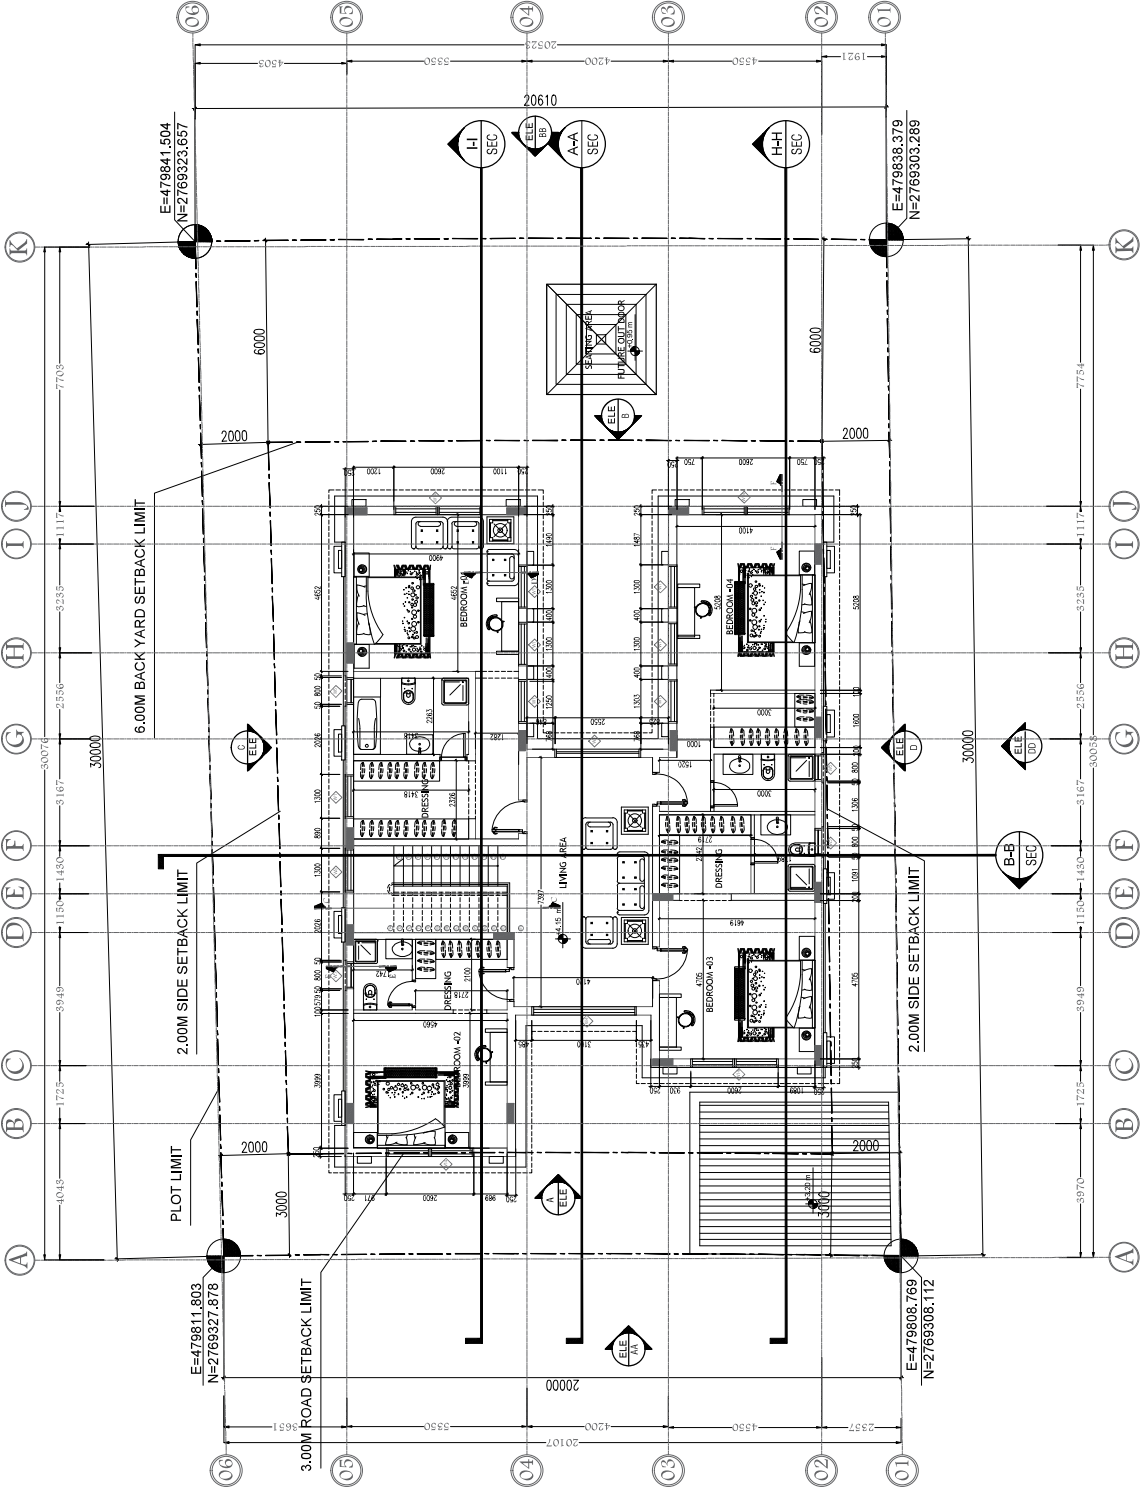

FIRST FLOOR PLAN

SCALE: NTS